


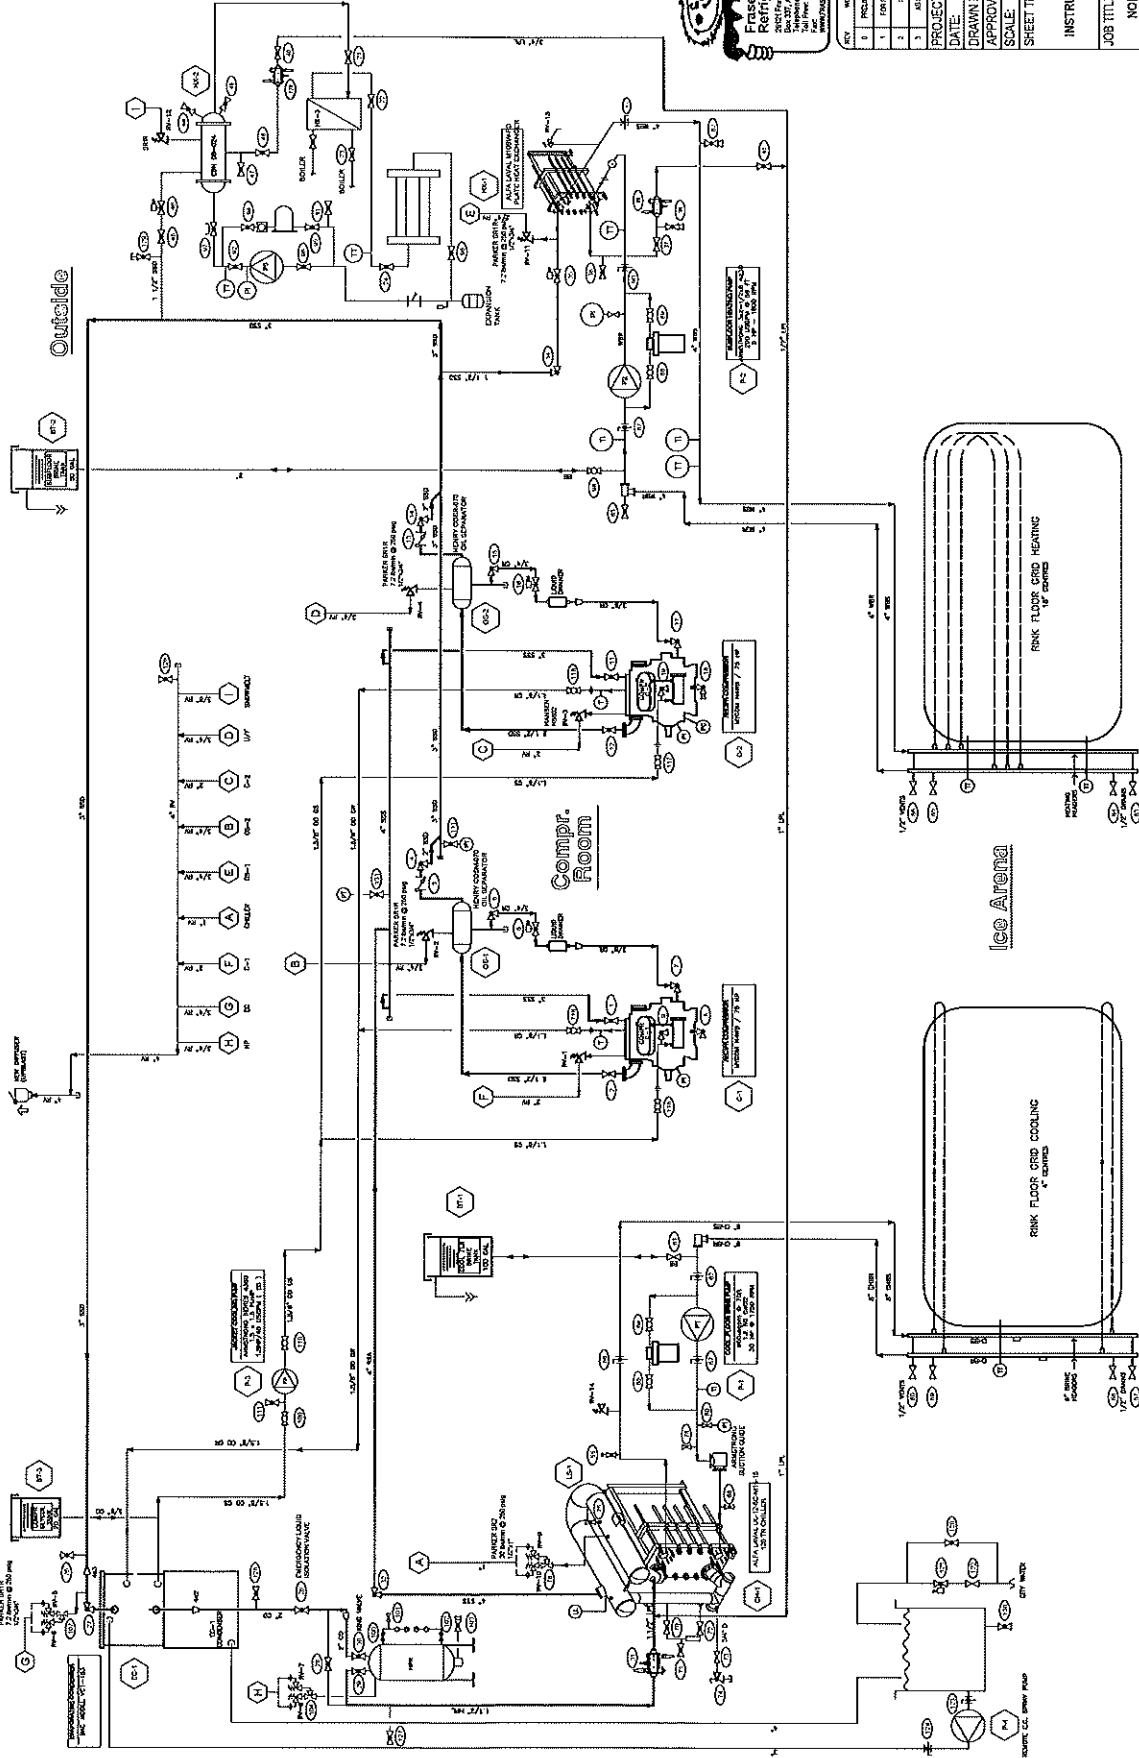

Fraser Valley Refrigeration Ltd.
 2601 Fraser Highway, Unit 270
 Surrey, BC V4N 1B4
 Tel: 604-585-8444
 Fax: 604-585-7722
 WWW.FRASERVALLREFRIG.COM

REV	DATE	BY	CHKD
1	PROJ. #	407063	
2	DATE	20-SEP-20	
3	DRAWN BY	JC	
4	APPROVED	MH	
5	SCALE	N/A	

DRAWING #	REV.
407063-R1	3

JOB TITLE:
 NOR VAL ARENA
 3351 Park Drive,
 Armstrong, BC
 V0E 1B0

SHEET TITLE:
 PIPING &
 INSTRUMENT DIAGRAM
 (P&ID)